 
 

 
 
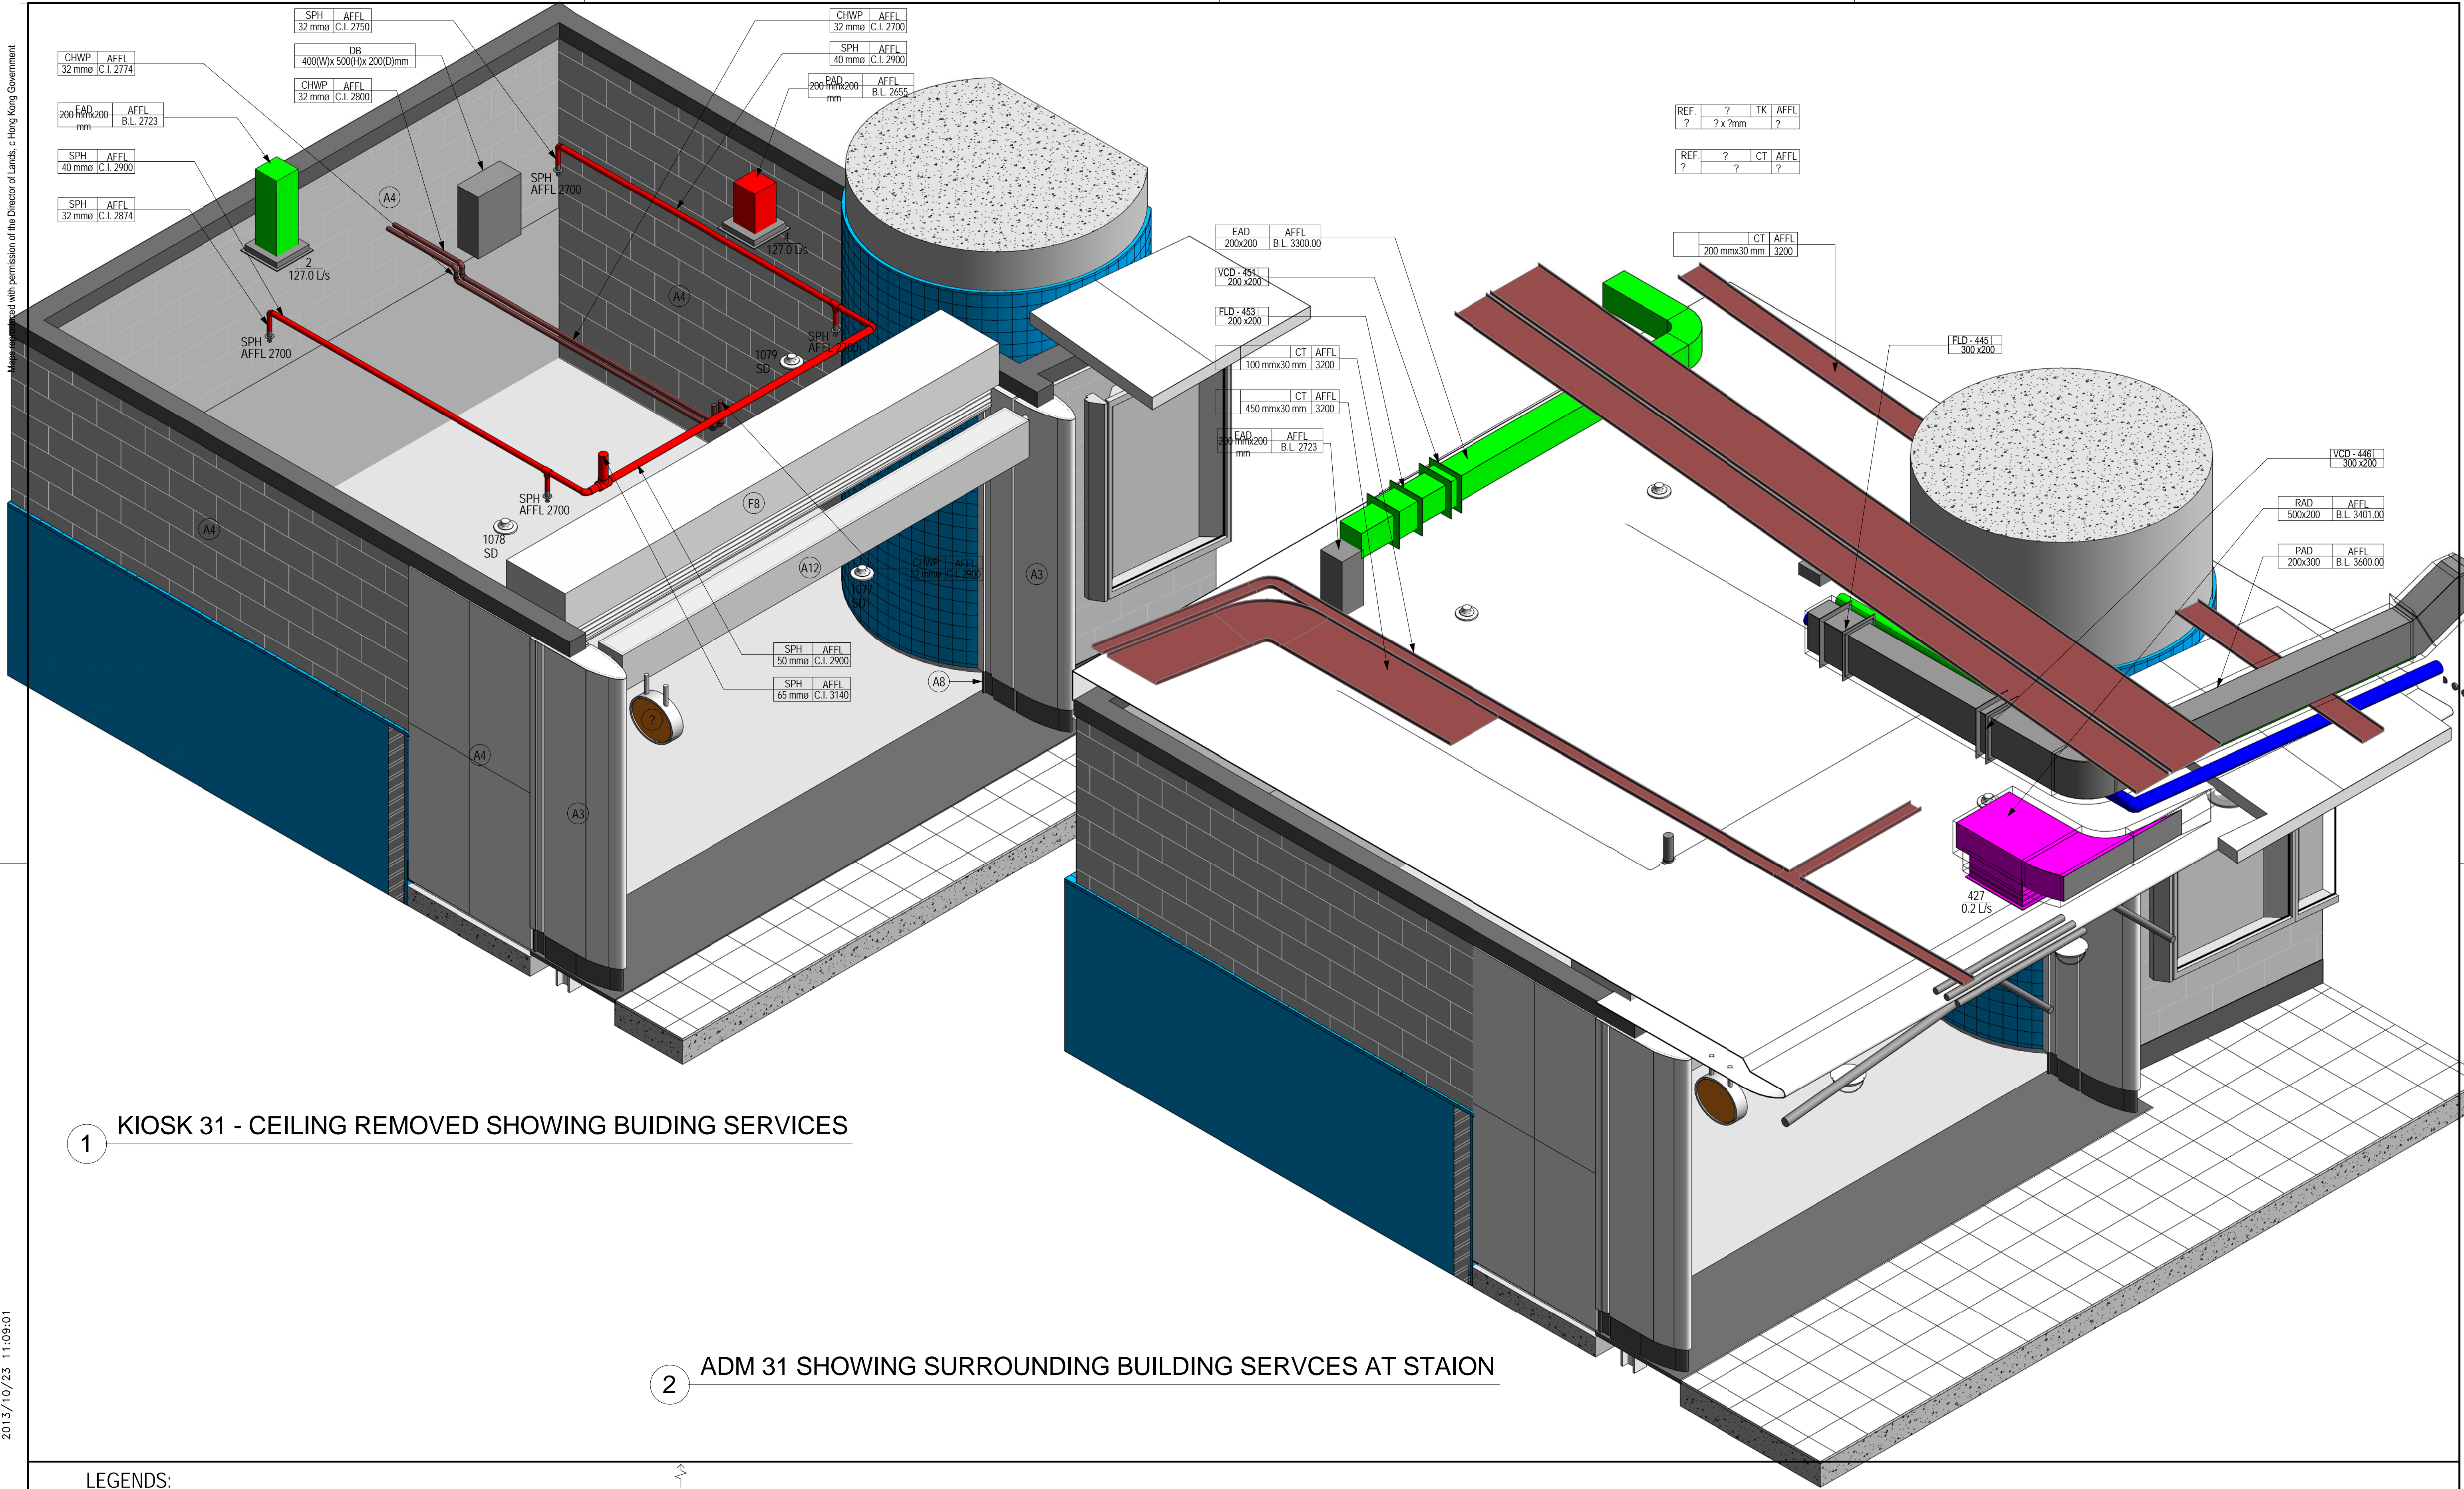


LEGENDS:

	SWITCH CONTROL PANEL		SMOKE DETECTOR		SPRINKLER HEAD		AIR GRILL		CHILLER WATER PIPE		SPRINKLER PIPE
--	----------------------	--	----------------	--	----------------	--	-----------	--	--------------------	--	----------------

KEY PLAN 																																																																																																																								</
---	--	---	---	--



1 KIOSK 31 - CEILING REMOVED SHOWING BUIDING SERVICES

2 ADM 31 SHOWING SURROUNDING BUILDING SERVCS AT STAION

LEGENDS:


	SWITCH CONTROL PANEL		SMOKE DETECTOR		SPRINKLER HEAD		AIR GRILL		CHILLER WATER PIPE		SPRINKLER PIPE
--	----------------------	--	----------------	--	----------------	--	-----------	--	--------------------	--	----------------

KEY PLAN							DRAWN	Author	TITLE				
							DESIGNED	Designer					
							CHECKED	Checker					
							APPROVED	Approver					
							DATE	06/22/11	OPERATION DIVISION				
							DO NOT SCALE DRAWINGS. ALL DIMENSIONS SHALL BE VERIFIED ON SITE. © MTR CORPORATION LIMITED 2008. COPYRIGHT IN RESPECT OF THIS DRAWING / DOCUMENT IS OWNED BY THE MTR CORPORATION LIMITED OF HONG KONG. NO REPRODUCTION OF THE DRAWING / DOCUMENT OR ANY PART BY WHATEVER MEANS IS PERMITTED WITHOUT THE PRIOR WRITTEN CONSENT OF THE MTR CORPORATION LIMITED.						
REV		DESCRIPTION	BY	DATE	APP		BIM REF.		SCALE	1 : 50(A1)	FIGURE NO.	A10/402	REVISION




 SWITCH CONTROL PANEL
 SMOKE DETECTOR
 SPRINKLER HEAD
 AIR GRILL
 CHILLER WATER PIPE
 SPRINKLER PIPE


KEY PLAN						DRAWN	Author	CONTRACTOR		TITLE		
						DESIGNED	Designer					
						CHECKED	Checker					
						APPROVED	Approver					
						DATE	06/22/11					
						DO NOT SCALE DRAWINGS. ALL DIMENSIONS SHALL BE VERIFIED ON SITE. © MTR CORPORATION LIMITED 2008. COPYRIGHT IN THIS DRAWING DOCUMENT IS OWNED BY THE MTR CORPORATION LIMITED. NO PART OF THIS DRAWING DOCUMENT OR ANY PART BY WHATEVER MEANS IS PERMITTED TO BE REPRODUCED OR TRANSMITTED IN ANY FORM OR BY ANY MEANS WITHOUT THE PRIOR WRITTEN CONSENT OF THE MTR CORPORATION LIMITED.		OPERATION DIVISION				
								BIM REF.				
REV	DESCRIPTION	BY	DATE	APP			SCALE	FIGURE NO.	REV.			
							As indicated(A1)	A10/403				

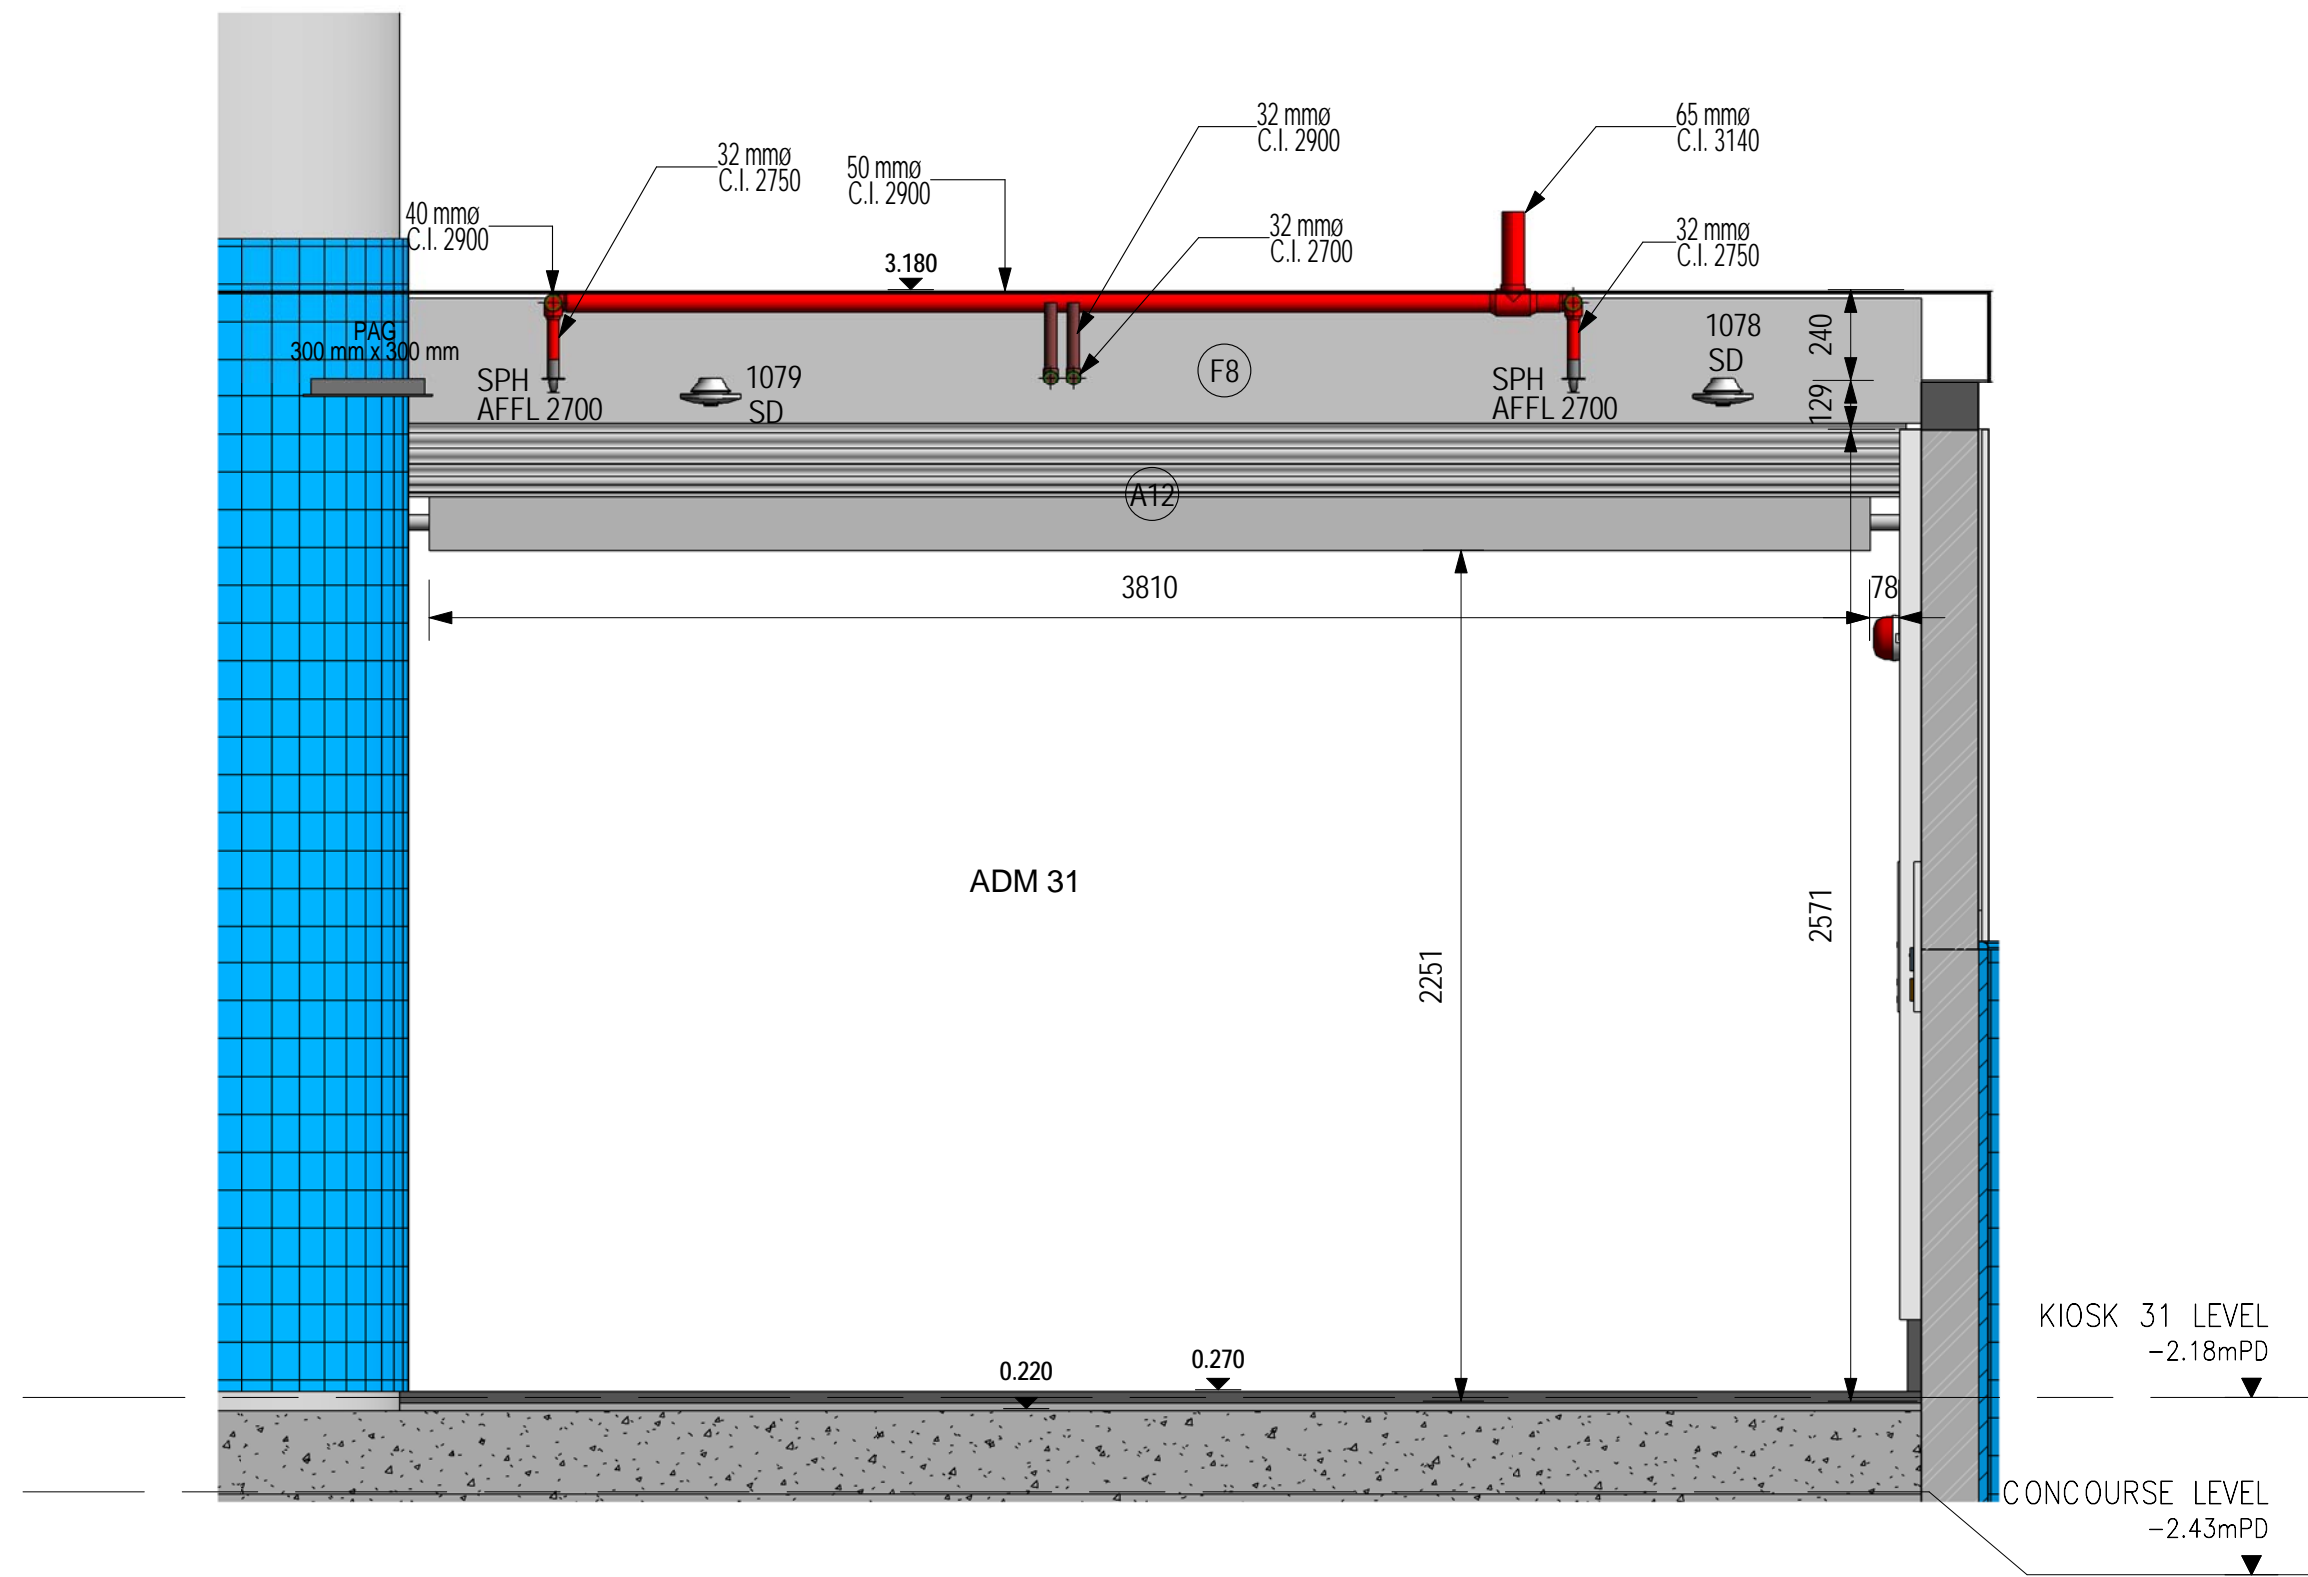


1 ELEVATION 1
1 : 20

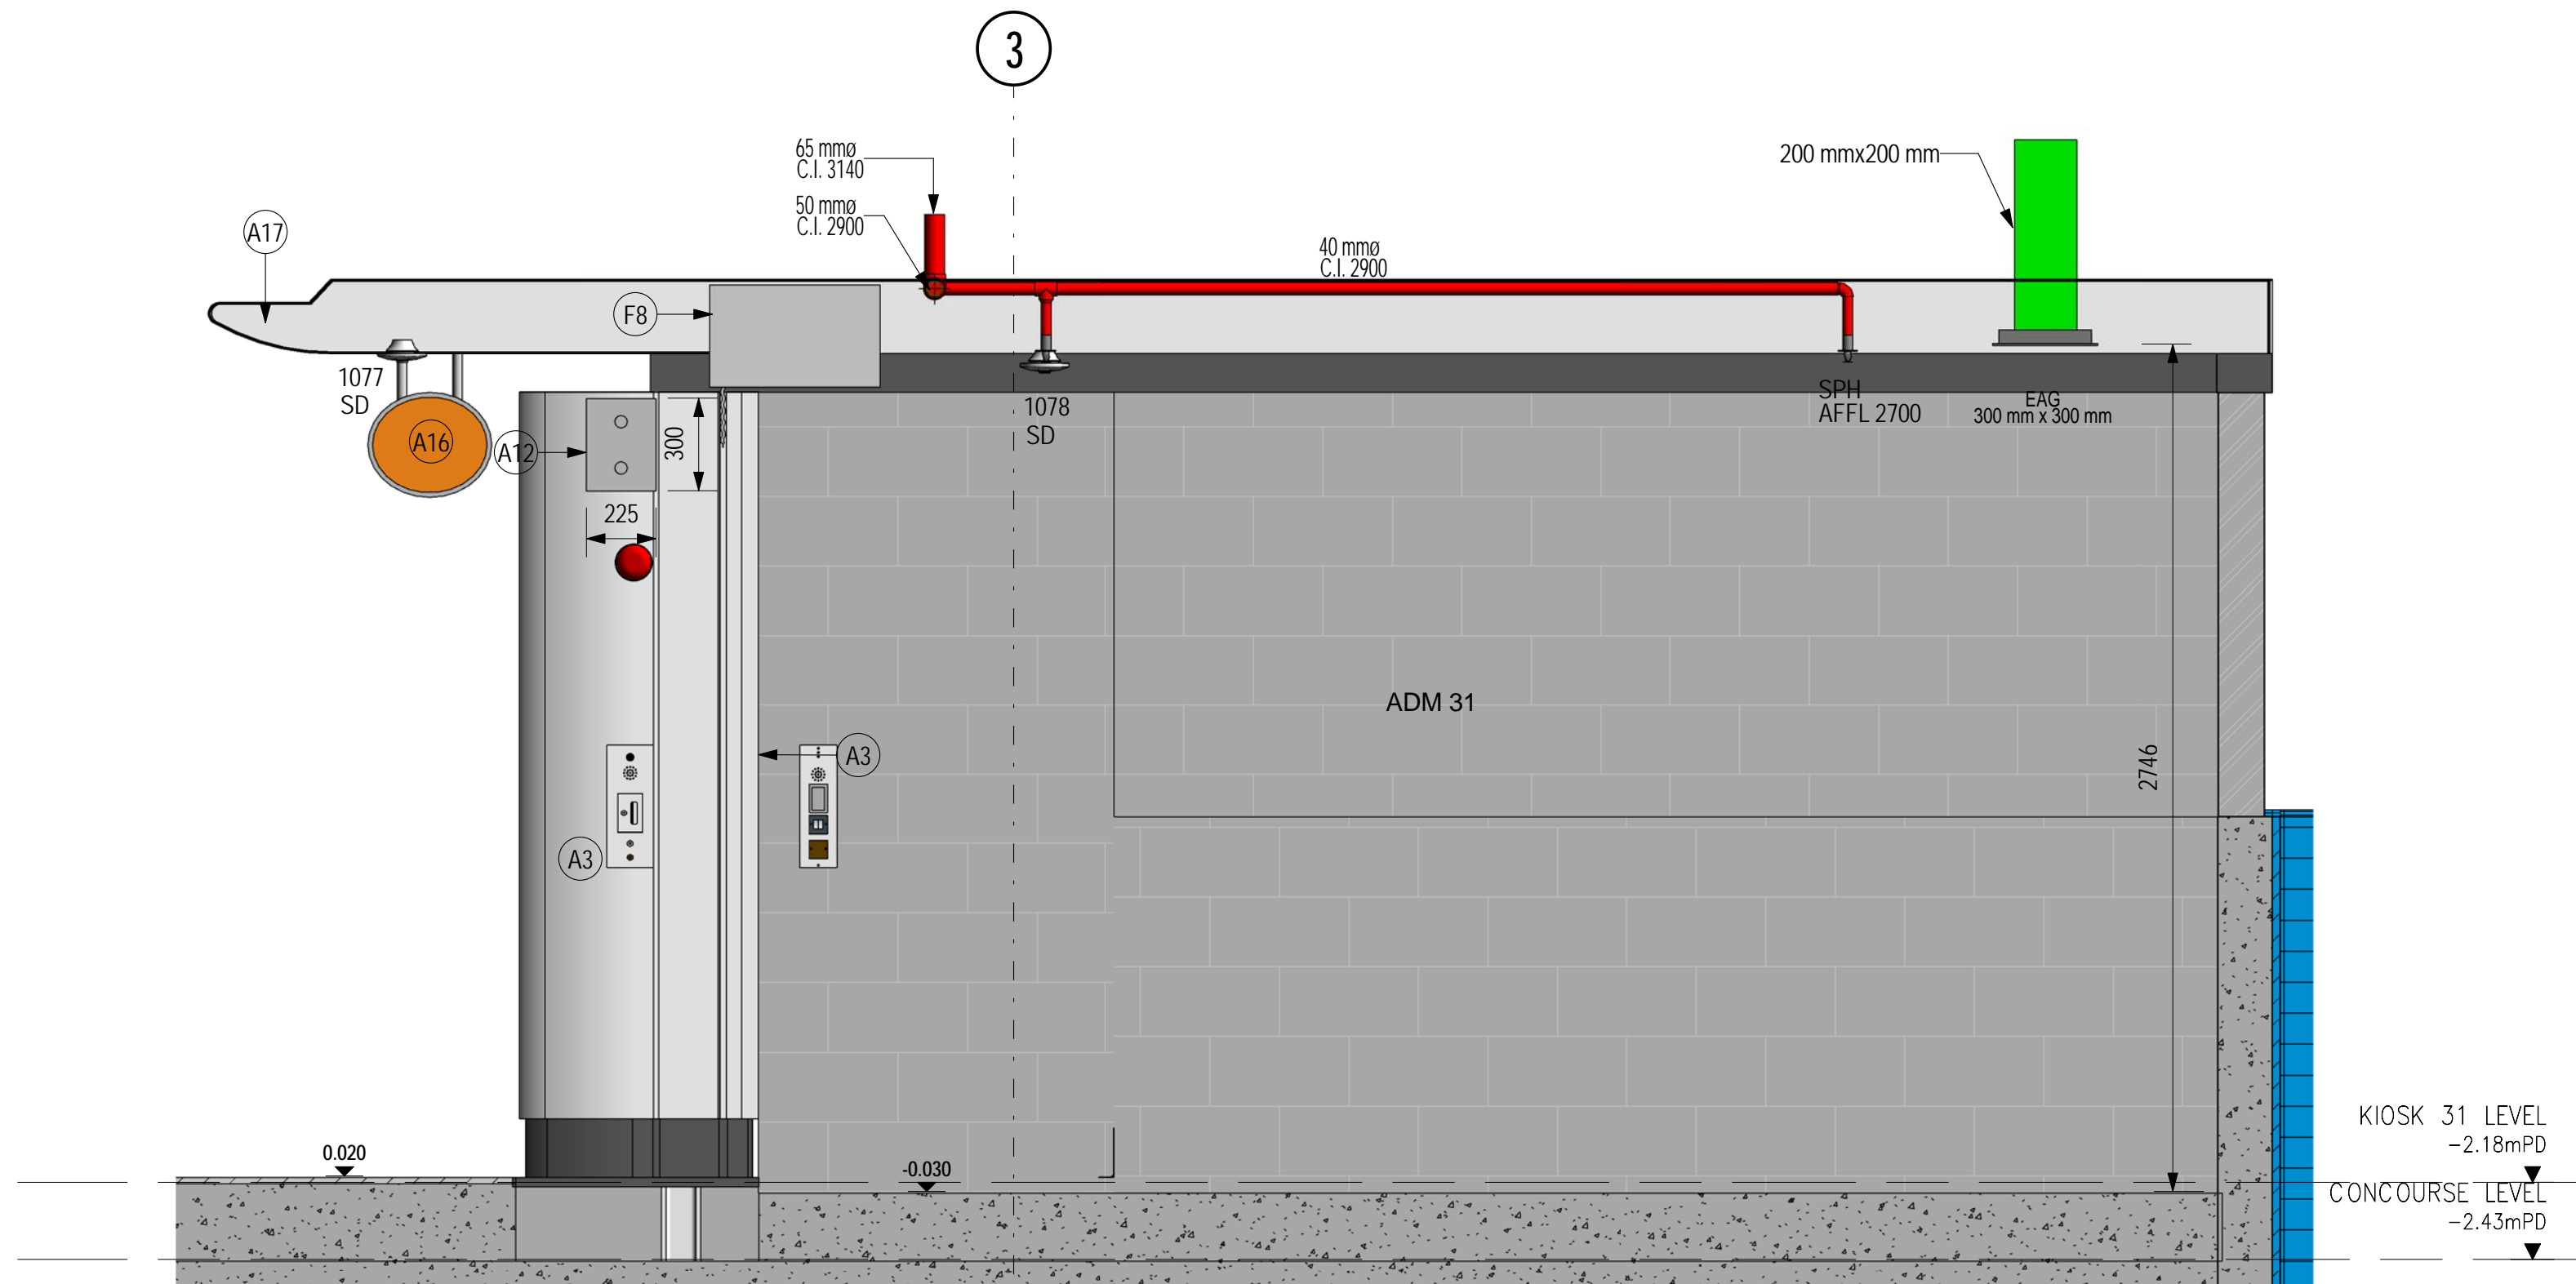

2 ELEVATION 2
1 : 20

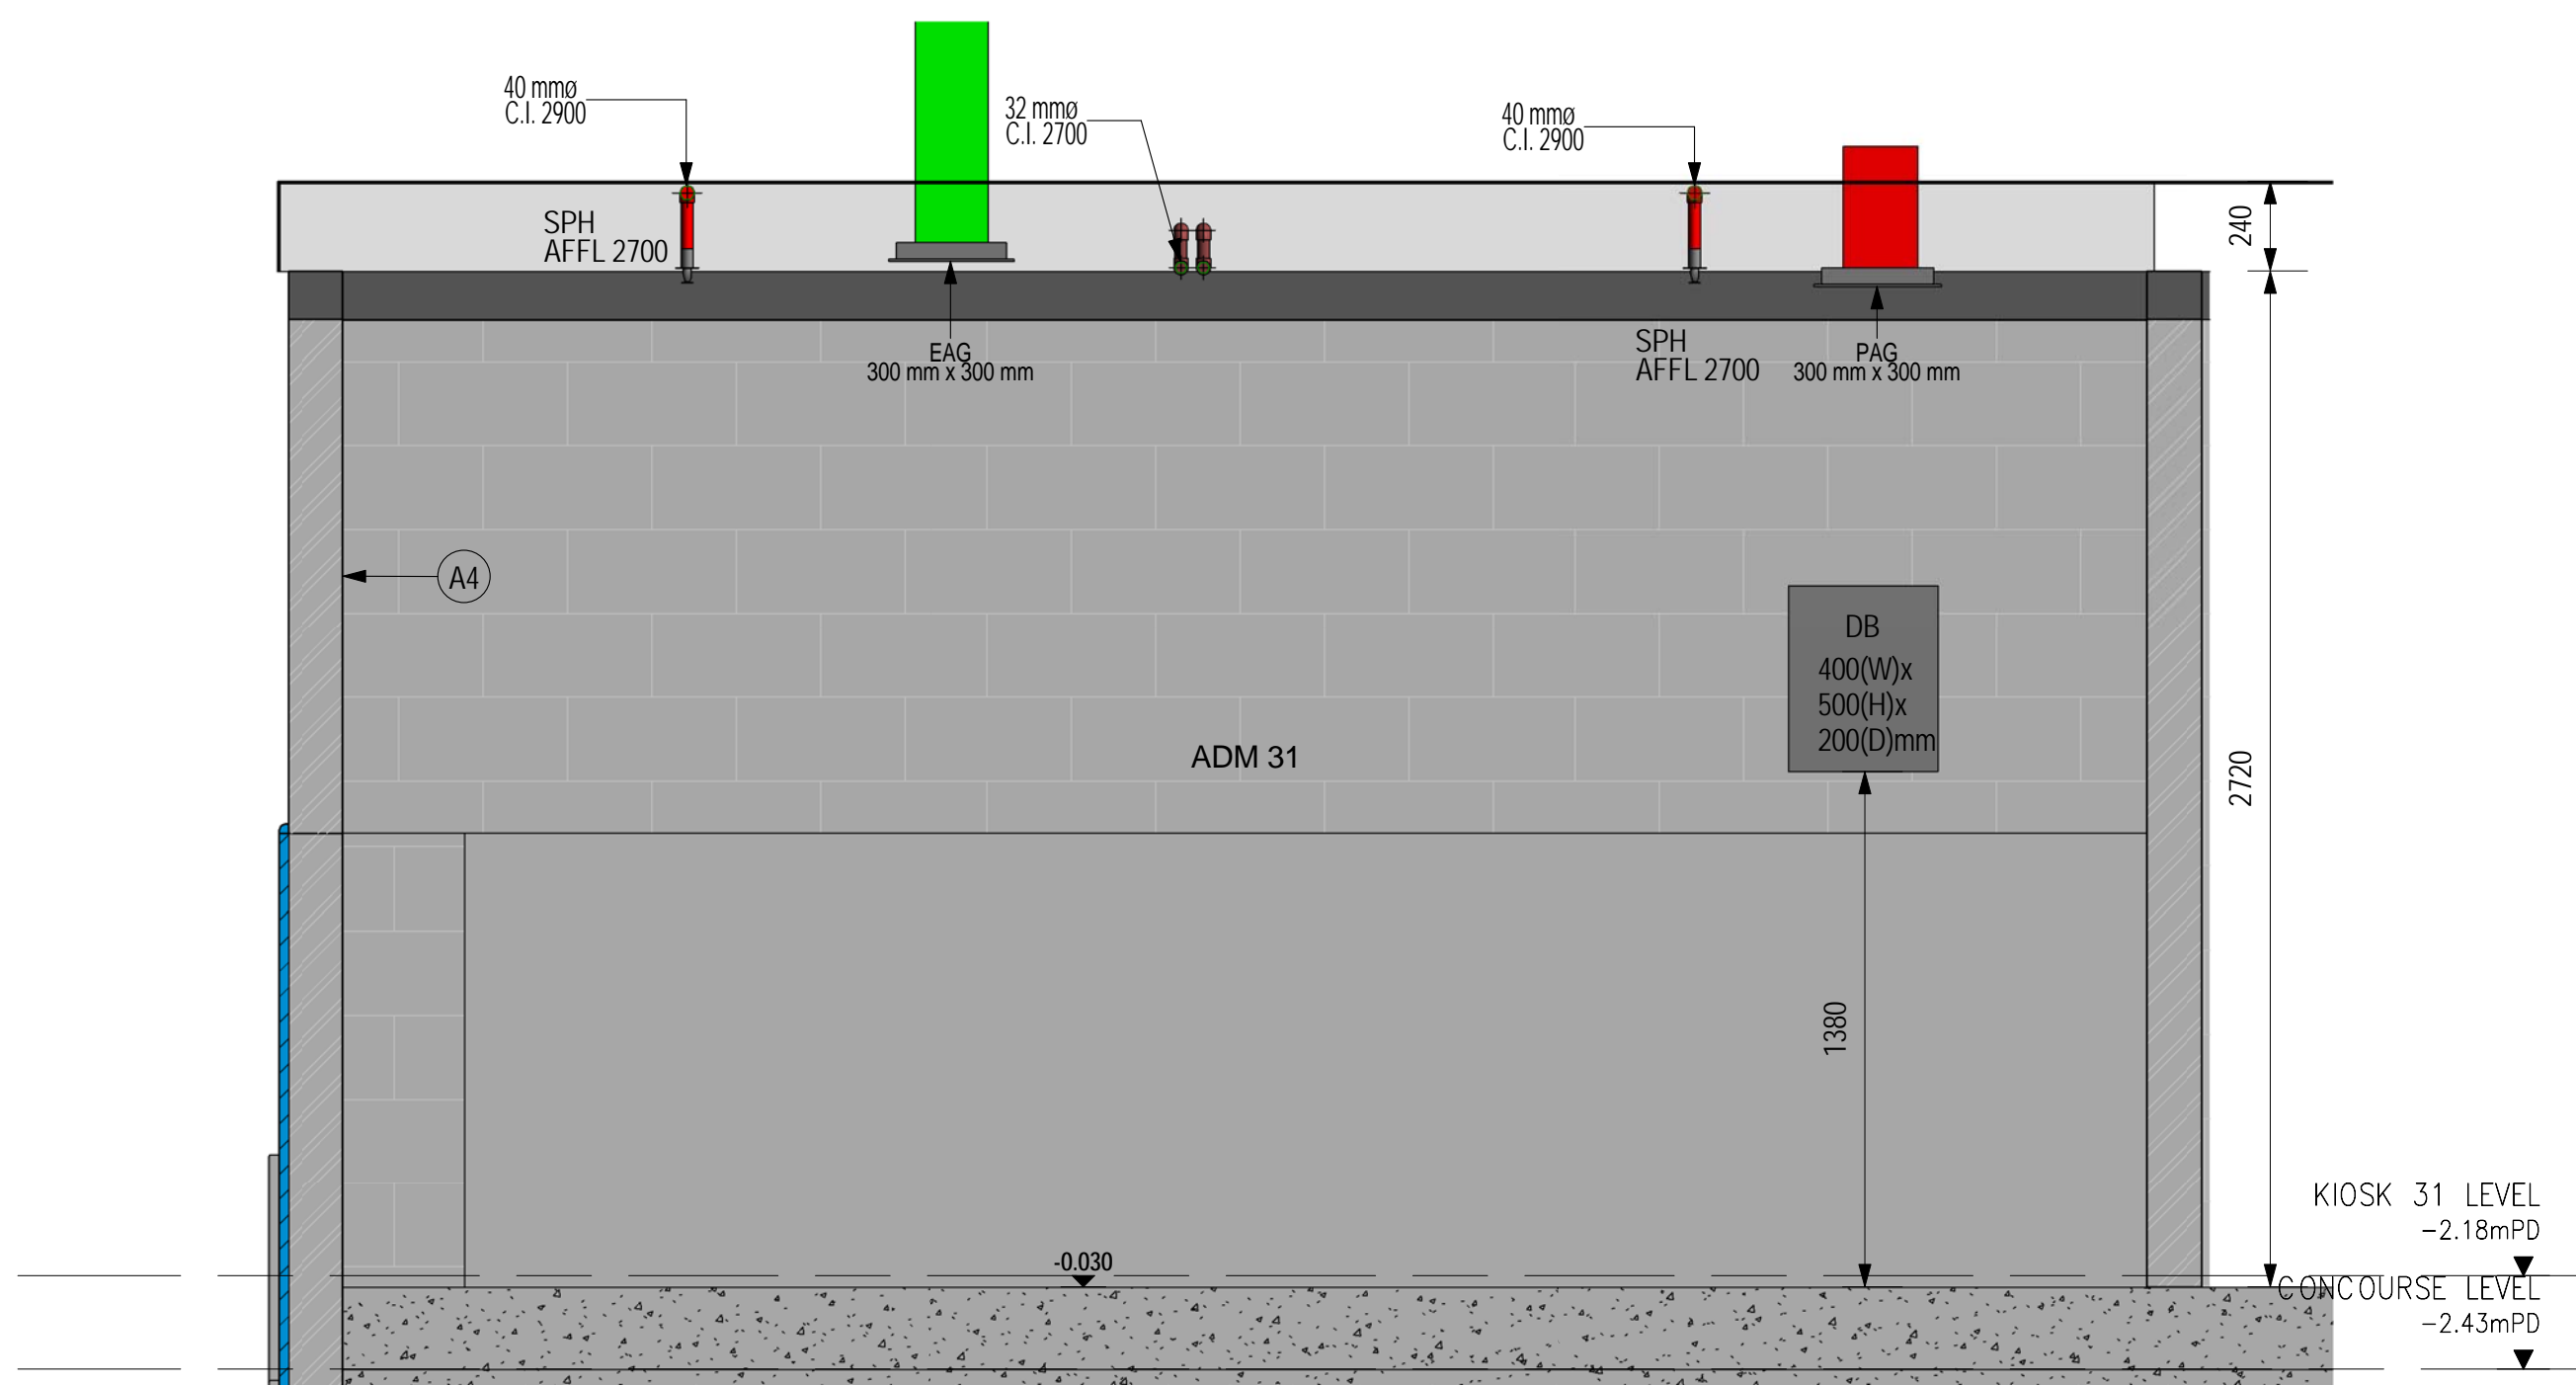


3 ELEVATION 3
1 : 20

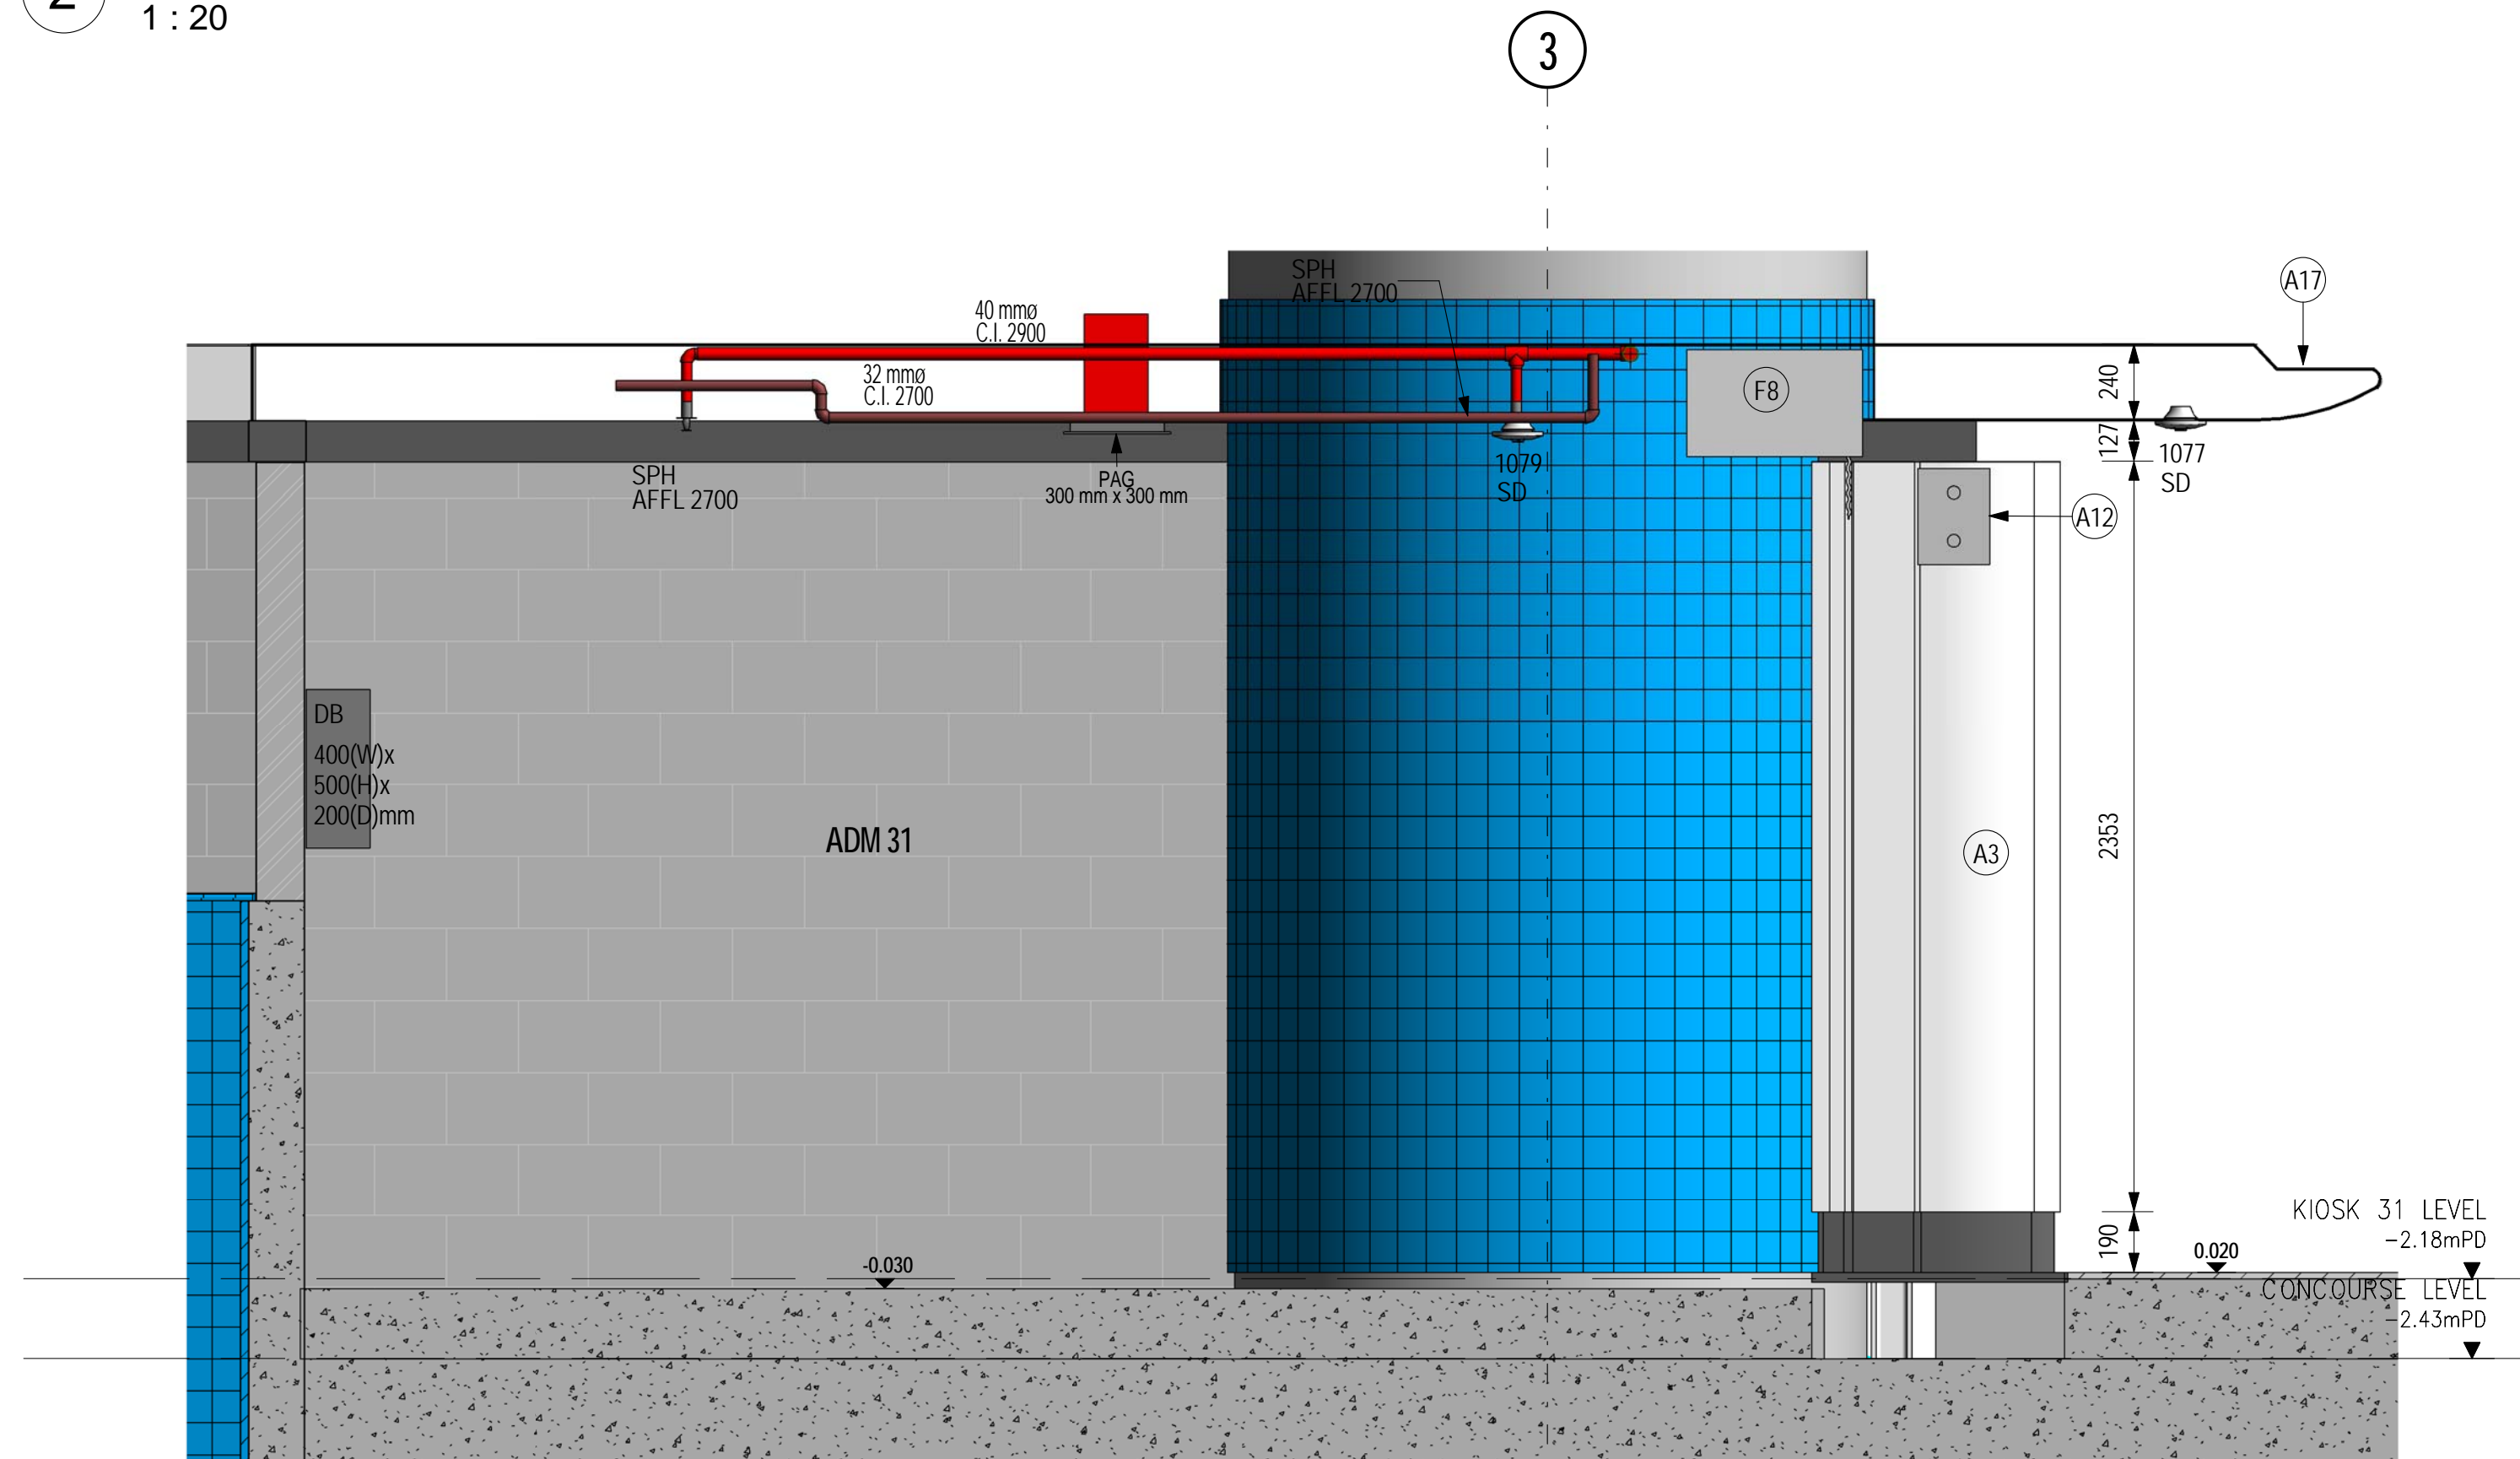

4 ELEVATION 4
1 : 20

KEY PLAN							DRAWN	Author	TITLE				
							DESIGNED	Designer					
							CHECKED	Checker					
							APPROVED	Approver					
							DATE	06/22/11	OPERATION DIVISION				
							DO NOT SCALE DRAWINGS. ALL DIMENSIONS SHALL BE VERIFIED ON SITE. © MTR CORPORATION LIMITED 2008. COPYRIGHT IN RESPECT OF THIS DRAWING / DOCUMENT IS OWNED BY THE MTR CORPORATION LIMITED OF HONG KONG. NO REPRODUCTION OF THE DRAWING / DOCUMENT OR ANY PART BY WHATEVER MEANS IS PERMITTED WITHOUT THE PRIOR WRITTEN CONSENT OF THE MTR CORPORATION LIMITED.						
	REV	DESCRIPTION	BY	DATE	APP		BIM REF.		SCALE	1 : 20(A1)	FIGURE NO.	A10/404	REV.

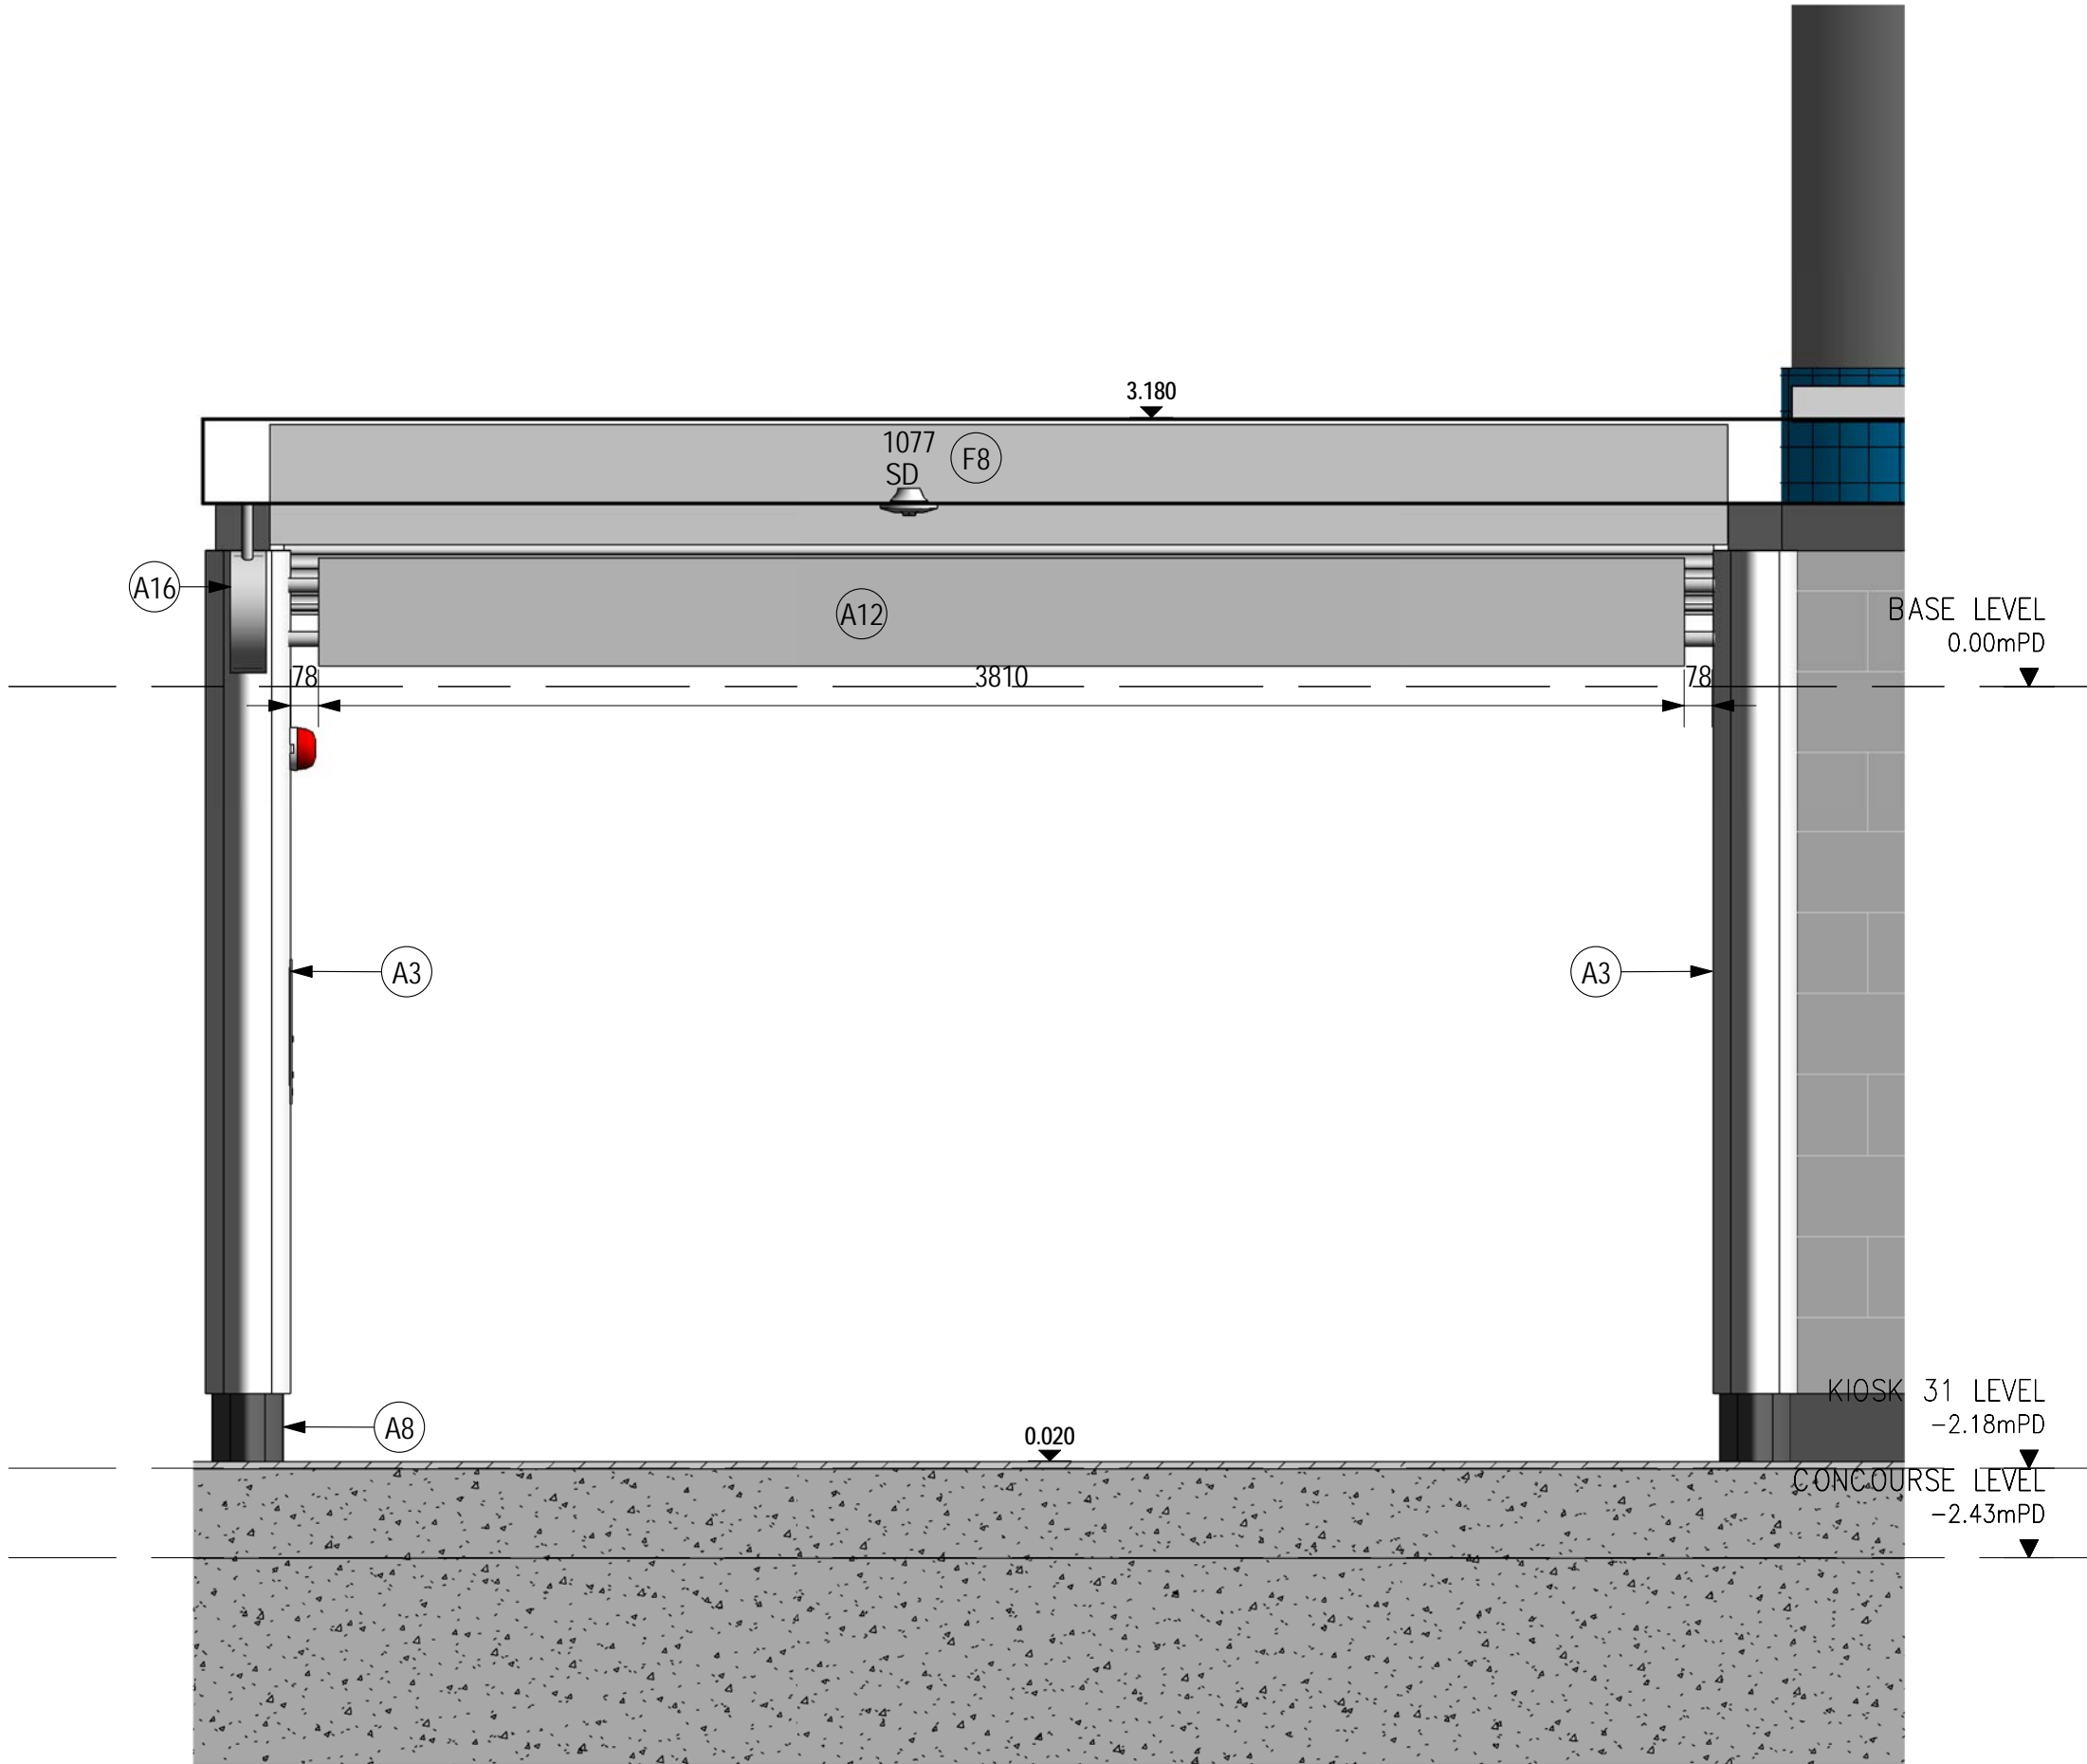

1

FRONT ELEVATION

1 : 20

Electrical Equipment Schedule					
Level	Family and Type	H	W	D	Type Mark
KIOSK 31 LEVEL	EL-ELE-MTR-Control Panel: ELE-MTR-Control Panel	500	400	200	DB

Fire Alarm Device Schedule			
Level	Family and Type	Type Mark	Mark
CONCOURSE LEVEL	FS-FAD-MTR-Smoke Detector: FAD-MTR-Smoke Detector	SD	1077
KIOSK 31 LEVEL	FS-FAD-MTR-Smoke Detector: FAD-MTR-Smoke Detector Type 2	SD	1078
KIOSK 31 LEVEL	FS-FAD-MTR-Smoke Detector: FAD-MTR-Smoke Detector Type 2	SD	1079

Grand total: 3

Sprinkler Schedule			
Level	Family and Type	Type Mark	Offset
KIOSK 31 LEVEL	FS-SPR-MTR-Sprinkler Head: SPR-MTR-Sprinkler Head-Under Ceiling Soffit	SPH	2700

Grand total: 4

LEGEND

ARCHITECTURAL COMPOHENTS

- A1

1 HR. F.R. DURASTEEL PARTITION COMPOSED OF ONE LAYER OF 6.3 MM THK. DURASTEEL PANEL FRAMED BY 50 MM X 50 MM X 6MM THK. STEEL ANGLES WITH GREY PPC ALUMINIUM PANELS ON KIOSK SIDES.
- A2

1 HR. F.R. CEILING COMPOSED OF 9MM. THK. PROMATECT-H BOARD SUSPENDED BY 50 MM X 30 MM X 3 MM THK. STEEL CHANNEL SECTION.
- A3

GREY PPC ALUMINIUM FIN PROFILE ON CONCEALED HOOK ON FIXINGS.
- A4

GREY PPC ALUMINIUM PANELS ON CONCEALED HOOK ON FIXINGS.
- A5

1 HR. F.R. STEEL DOORS WHERE REQUIRED, LEAF & FRAME TO BE P.P.C. GREY FINISH.
- A6

1580MM X 1040MM X 54MM THK. HAIRLINE STAINLESS STEEL ADVERTISING PANELS BY OTHERS. (OPTIONAL)
- A7

2825MM X 1050MM X 2MM THK. SELF SPAN G.M.S. PROFILE DECK.
- A8

EG STEEL WITH MAT BLACK PPC SKIRTINGS.
- A9

600 MM WIDE WITHOUT POLY CARBONATE SHUTTER OR 811MM WIDE WITHOUT POLY CARBONATE SHUTTER ZIMBABWE BLACK FLAME TEXTURED GRANITE RAMP WITH STAINLESS STEEL NOSING & THRESHOLD, 300MM WIDE POLISHED ZIMBABWE BAND AT EACH SIDES.
- A10

1.5 MM THK. ALUMINIUM STRUCTURE CAPPING PANELS WITH P.P.C. BLACK FINISH.
- A11

1.5 MM THK. ALUMINIUM COVER PANEL WITH P.P.C. GREY FINISH.
- A12

2 MM THK. EG STEEL WITH GREY PPC (COLOUR RAL 7035) FINISHES SIGN BOX AND OPAL POLYCARBONATE SHEET BACKING.
- A13

1.5 MM THK. HAIRLINE GMS SHOP NAME PLATES.
- A14

STEEL COLLAR
- A15

41MM X 21MM X 2.5 MM THK. UNISTRUT FIXED TO R.H.S.
- A16

2 MM THK. HAIRLINE STAINLESS STEEL OVAL HANGING SIGN BOX WITH OPAL POLYCARBONATE SHEETS ON BOTH SIDES.
- A17

1.5 MM THK. ALUMINIUM CANOPY FINISHED WITH WHITE PPC.
- A19

2 MM THK. HAIRLINE STAINLESS STEEL SHOP REGISTRATION PLATES.
- A20

50 MM X 27 MM X 3 MM THK. STEEL CHANNEL FRAME
- A21

1HR. F.R. 9 MM THK. PROMATECT-H BOARD FINISHED WITH BLACK EMUL SION PAINTS AND FIXED TO 50 MM X 27 MM X 3 MM THK. CHANNEL SECTION.
- A22

1.5 MM THK. ALUMINIUM COVER PANEL WITH P.P.C. BLACK FINISH.
- A23

GREY PPC ALUMINIUM ACCESS PANEL
- A24

1 HR. F.R. 6.3MM THK. DURASTEEL PANEL
- A25

1 HR. F.R. PARTITION COMPOSED OF 85 MM X 40 MM THK. STEEL CHANNEL FRAME AND 9 MM THK. PROMATECT-H BOARD ON BOTH SIDES, FINISHED WITH BLACK EMULSION PAINTS.

STRUCTURAL COMPONENTS

- S1

127 MM X 114 MM X 27 KG/M GRADE 43A GALVANIZED STEEL COLUMNS.
- S2

102 MM X 102 MM X 23.07 KG/M GRADE 43A GALVANIZED STEEL I BEAMS.
- S3

50 MM x 50MM x 5MM GRADE 43A GALVANIZED STEEL R.H.S. - 1 HR. F.R.
- S4

100 MM X 100 MM X 5 MM GRADE 43A GALVANIZED STEEL R.H.S.
- S5

100 MM x 50 MM x 5 MM GRADE 43A GALVANIZED STEEL R.H.S. - 1 HR. F.R.
- S6

127 MM x 64 MM x 14.90 KG/M GRADE 43A GALVANIZED STEEL CHANNEL.
- S7

152 MM x 89 MM x 23.84 KG/M GRADE 43A GALVANIZED STEEL CHANNEL.
- S8

152 MM x 76 MM x 17.88 KG/M GRADE 43A GALVANIZED STEEL CHANNEL.
- S9

10 MM THK. GRADE 43A GALVANIZED STEEL PLATE.
(ALL STRUCTURAL MEMBERS PROVIDE 1 HR. F.R.)

E & M SERVICE COMPONENTS

FIRE SHUTTER COMPONENTS

- EM1

FLUORESCENT DOWN LIGHT
- EM2

A.F.A. SMOKE DETECTOR
- EM3

FAST RESPONSE SPRINKLER HEAD
- EM4

SWITCH FOR CONCESSION LIGHTING
- EM5

A.F.A. BREAK GLASS
- EM6

M.C.B. BOARD
- EM7

150MM X 25MM SURFACE MOUNTED CABLE TRUNKING (FOR TENANTS SERVICE)
- EM8

DIA.25MM CABLE CONDUIT
- EM9

CHILLED WATER SUPPLY AND RETURN PIPES FOR A/C SYSTEM
- EM10

THERMOSTAT
- EM11

CONDENSATE DRAIN PIPE
- EM12

FAN COIL UNIT BY TENANTS
- EM13

GATE VALVE
- EM14

13M TWIN SOCKET OUTLET
- EM15

CO₂ 4.5/5.0 KG FIRE EXTINGUISHER
- EM16

LED INDICATOR FOR SMOKE DETECTOR
- EM17

JUNCTION BOX
- EM18

INTERCOM PANEL
- F1

HAIRLINE S/S SHUTTER GUIDE RAIL
- F2

BEACON
- F3

CONTROL BOX
- F4

SWITCH FOR ROLLER SHUTTER
- F5

MANUAL OVER-RIDE FOR SHUTTER
- F6

SHUTTER SWITCH WITH BREAK GLASS FRONT PANEL
- F7

SOUNDER
- F8

1 HR. SHUTTER MILD STEEL END PLATES
- F9

PHOTOSENSOR
- F10

PHOTOSENSOR REFLECTOR
- F11

HAIRLINE STAINLESS STEEL SHUTTER CURTAIN
- F12

1 HR. F.R. 2 STAGE FIRE SHUTTER

KEY PLAN					<div><div>DRAWN</div><div>DESIGNED</div><div>CHECKED</div><div>APPROVED</div><div>DATE</div></div> <div><div>Author</div><div>Designer</div><div>Checker</div><div>Approver</div><div>02/11/11</div></div> <div><div>DO NOT SCALE DRAWINGS. ALL DIMENSIONS SHALL BE VERIFIED ON SITE.</div><div>© MTR CORPORATION LIMITED 2008. COPYRIGHT IN RESPECT OF THIS DRAWING / DOCUMENT IS OWNED BY THE MTR CORPORATION LIMITED OF HONG KONG. NO REPRODUCTION OF THE DRAWING / DOCUMENT OR ANY PART BY WHATEVER MEANS IS PERMITTED WITHOUT THE PRIOR WRITTEN CONSENT OF THE MTR CORPORATION LIMITED.</div></div>							TITLE					
										CONTRACTOR							
										OPERATION DIVISION							
										BIM REF.							
REV	DESCRIPTION				BY	DATE	APP						SCALE	As indicated(A1)	FIGURE NO.	A42/405	REV.